
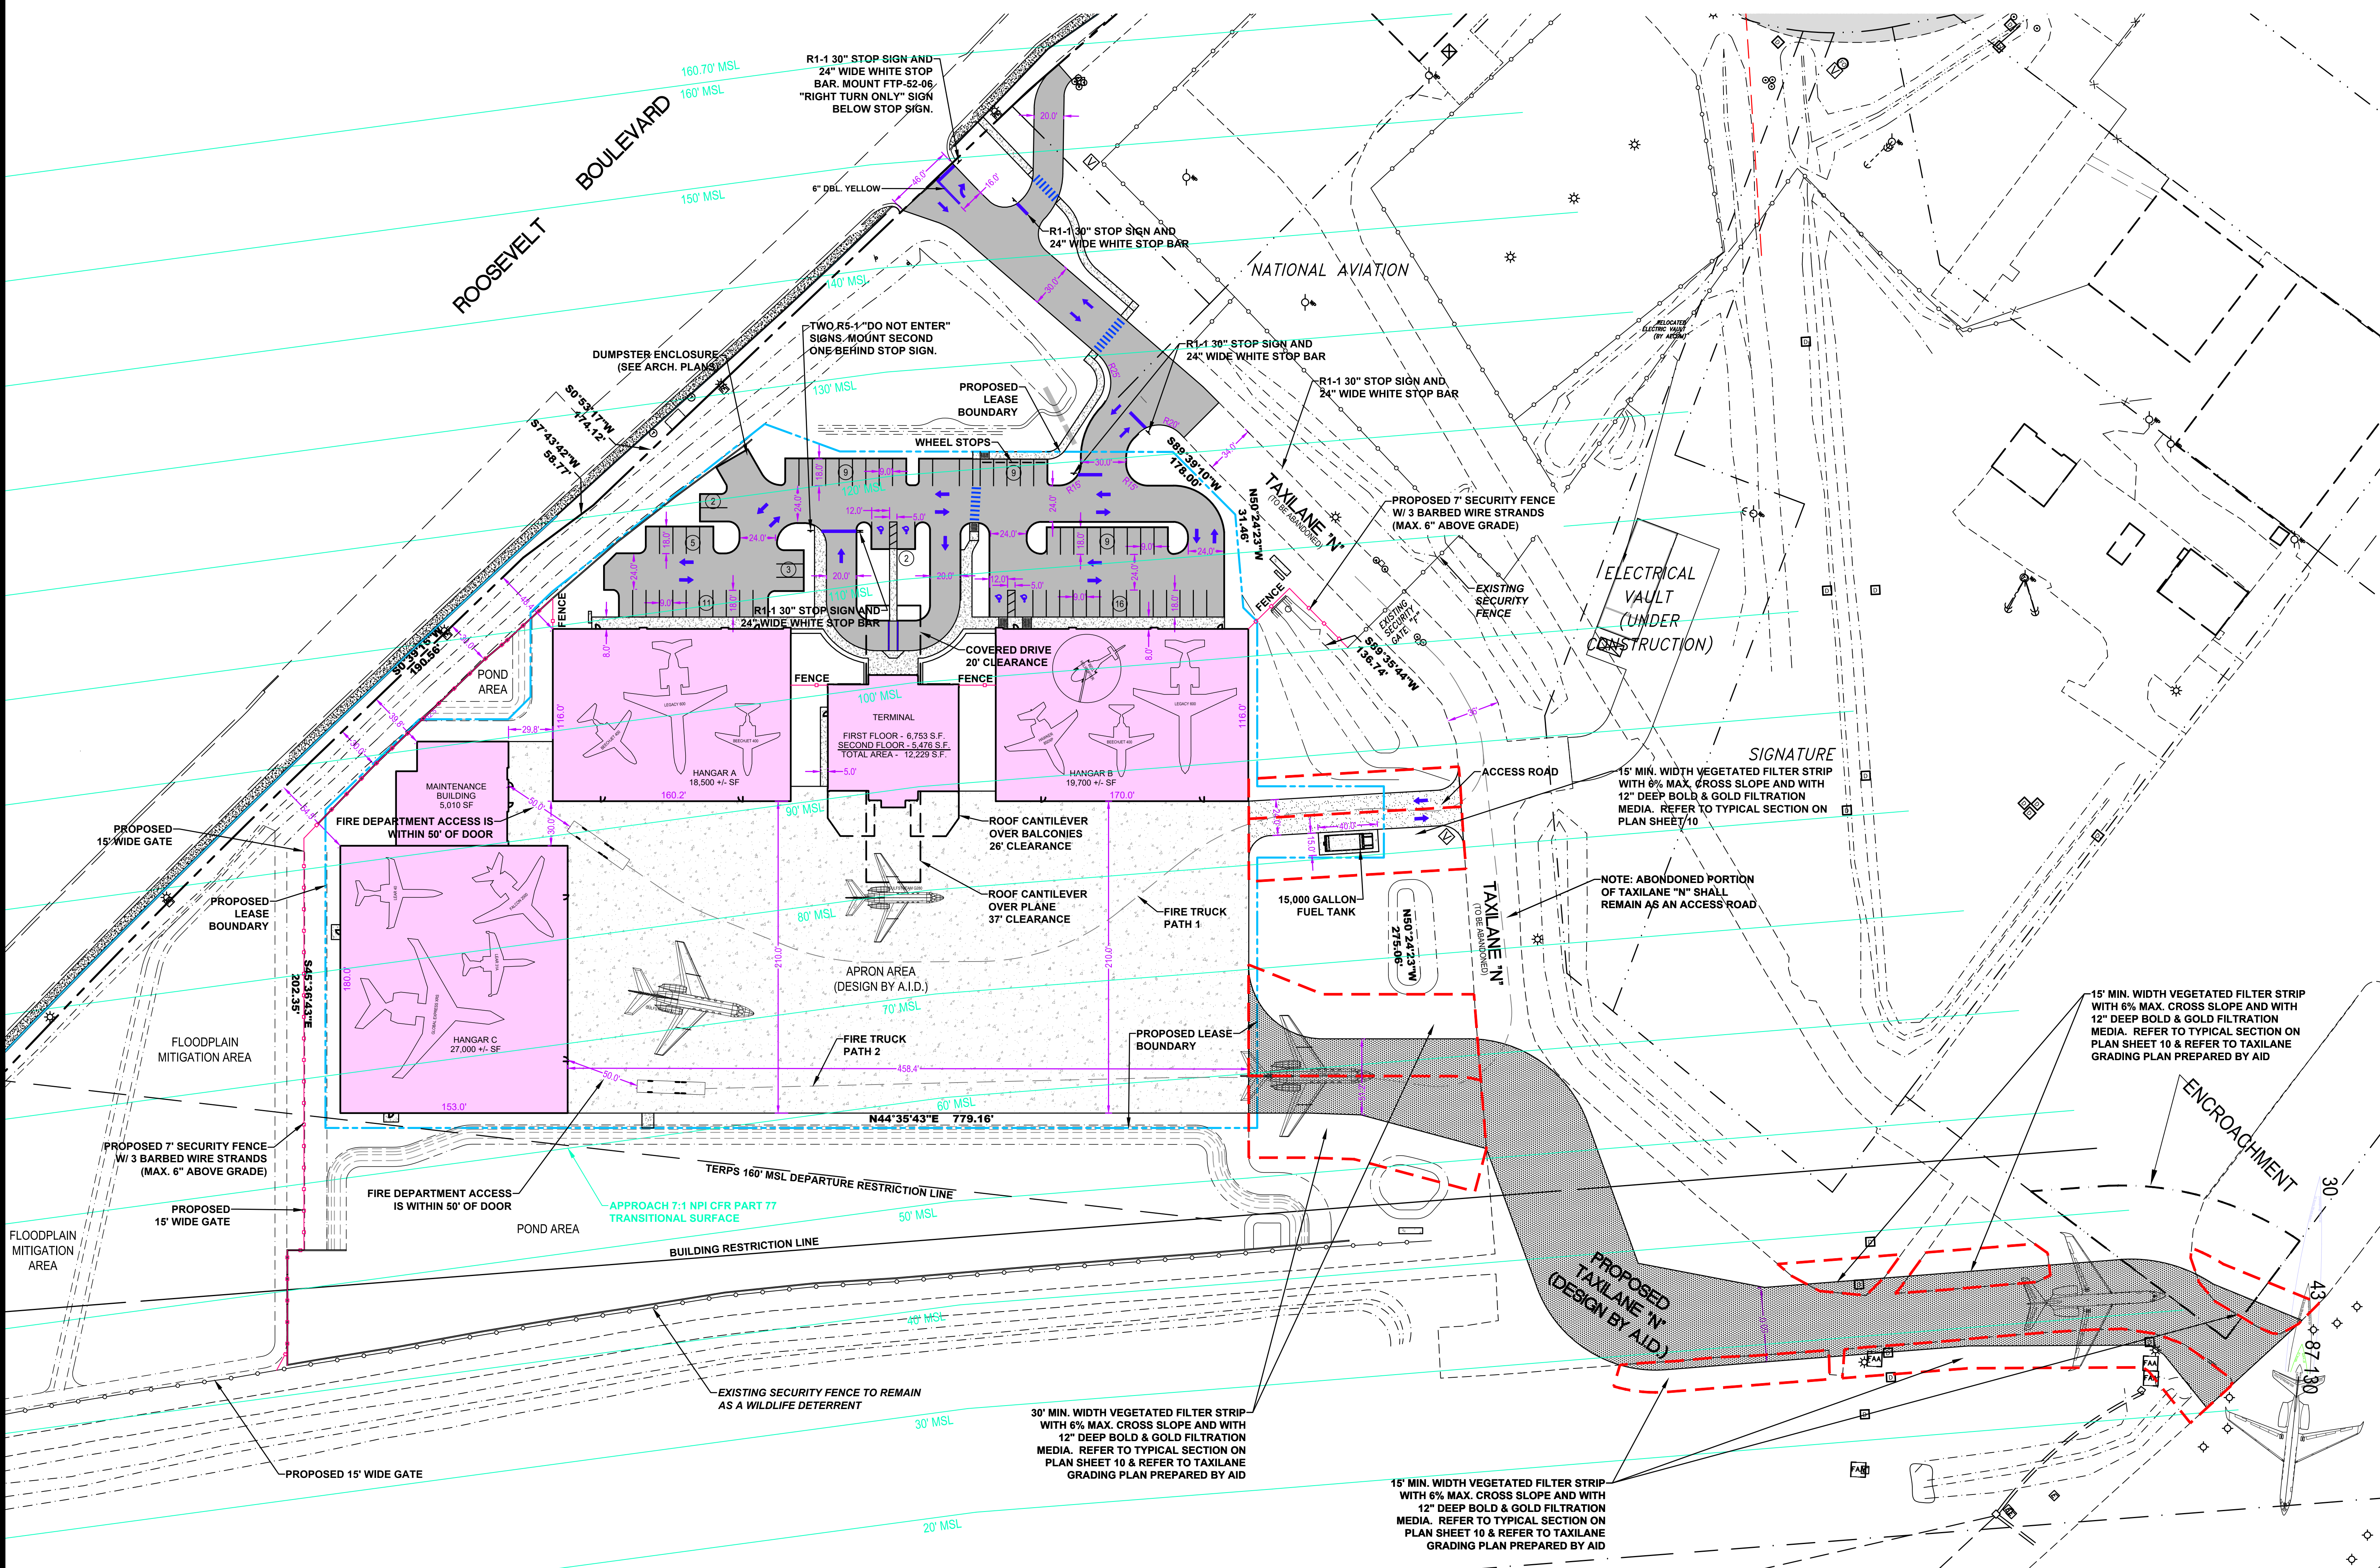


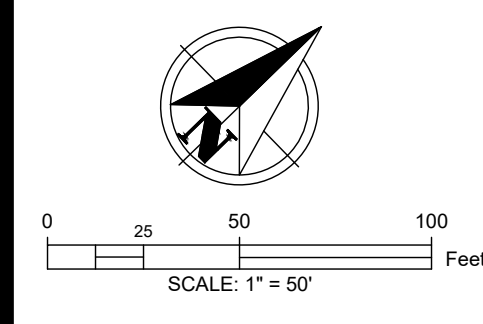

0

25

50

100

Feet

SCALE: 1" = 50'

Design: JPL

Drawn: ELM

Checked: JCL

Scale: 1" = 50'

Date: 11-10-2021

Job No.: 789-01

Copyright

ALL RIGHTS RESERVED

Landon, Moore & Associates, Inc.

represented interest of LANDON, MOORE & ASSOCIATES, INC.

DO NOT COPY OR REPRODUCE

ELITE AIR JET CENTER

SITE PLAN

ELITE AIR JET CENTER, LLC

100 SECOND AVENUE SOUTH, SUITE 707

ST. PETERSBURG, FL 33701

LMA

Landon, Moore & Associates, Inc.

Civil & Environmental Engineers - Planners - Surveyors

31622 U.S. 49 NORTH PALM HARBOR, FLORIDA 34684

Phone: (727)789-5010, Fax: (727)787-1394

Toll Free: 1-800-282-7980, WWW.LMAENG.COM

7

OF 16